


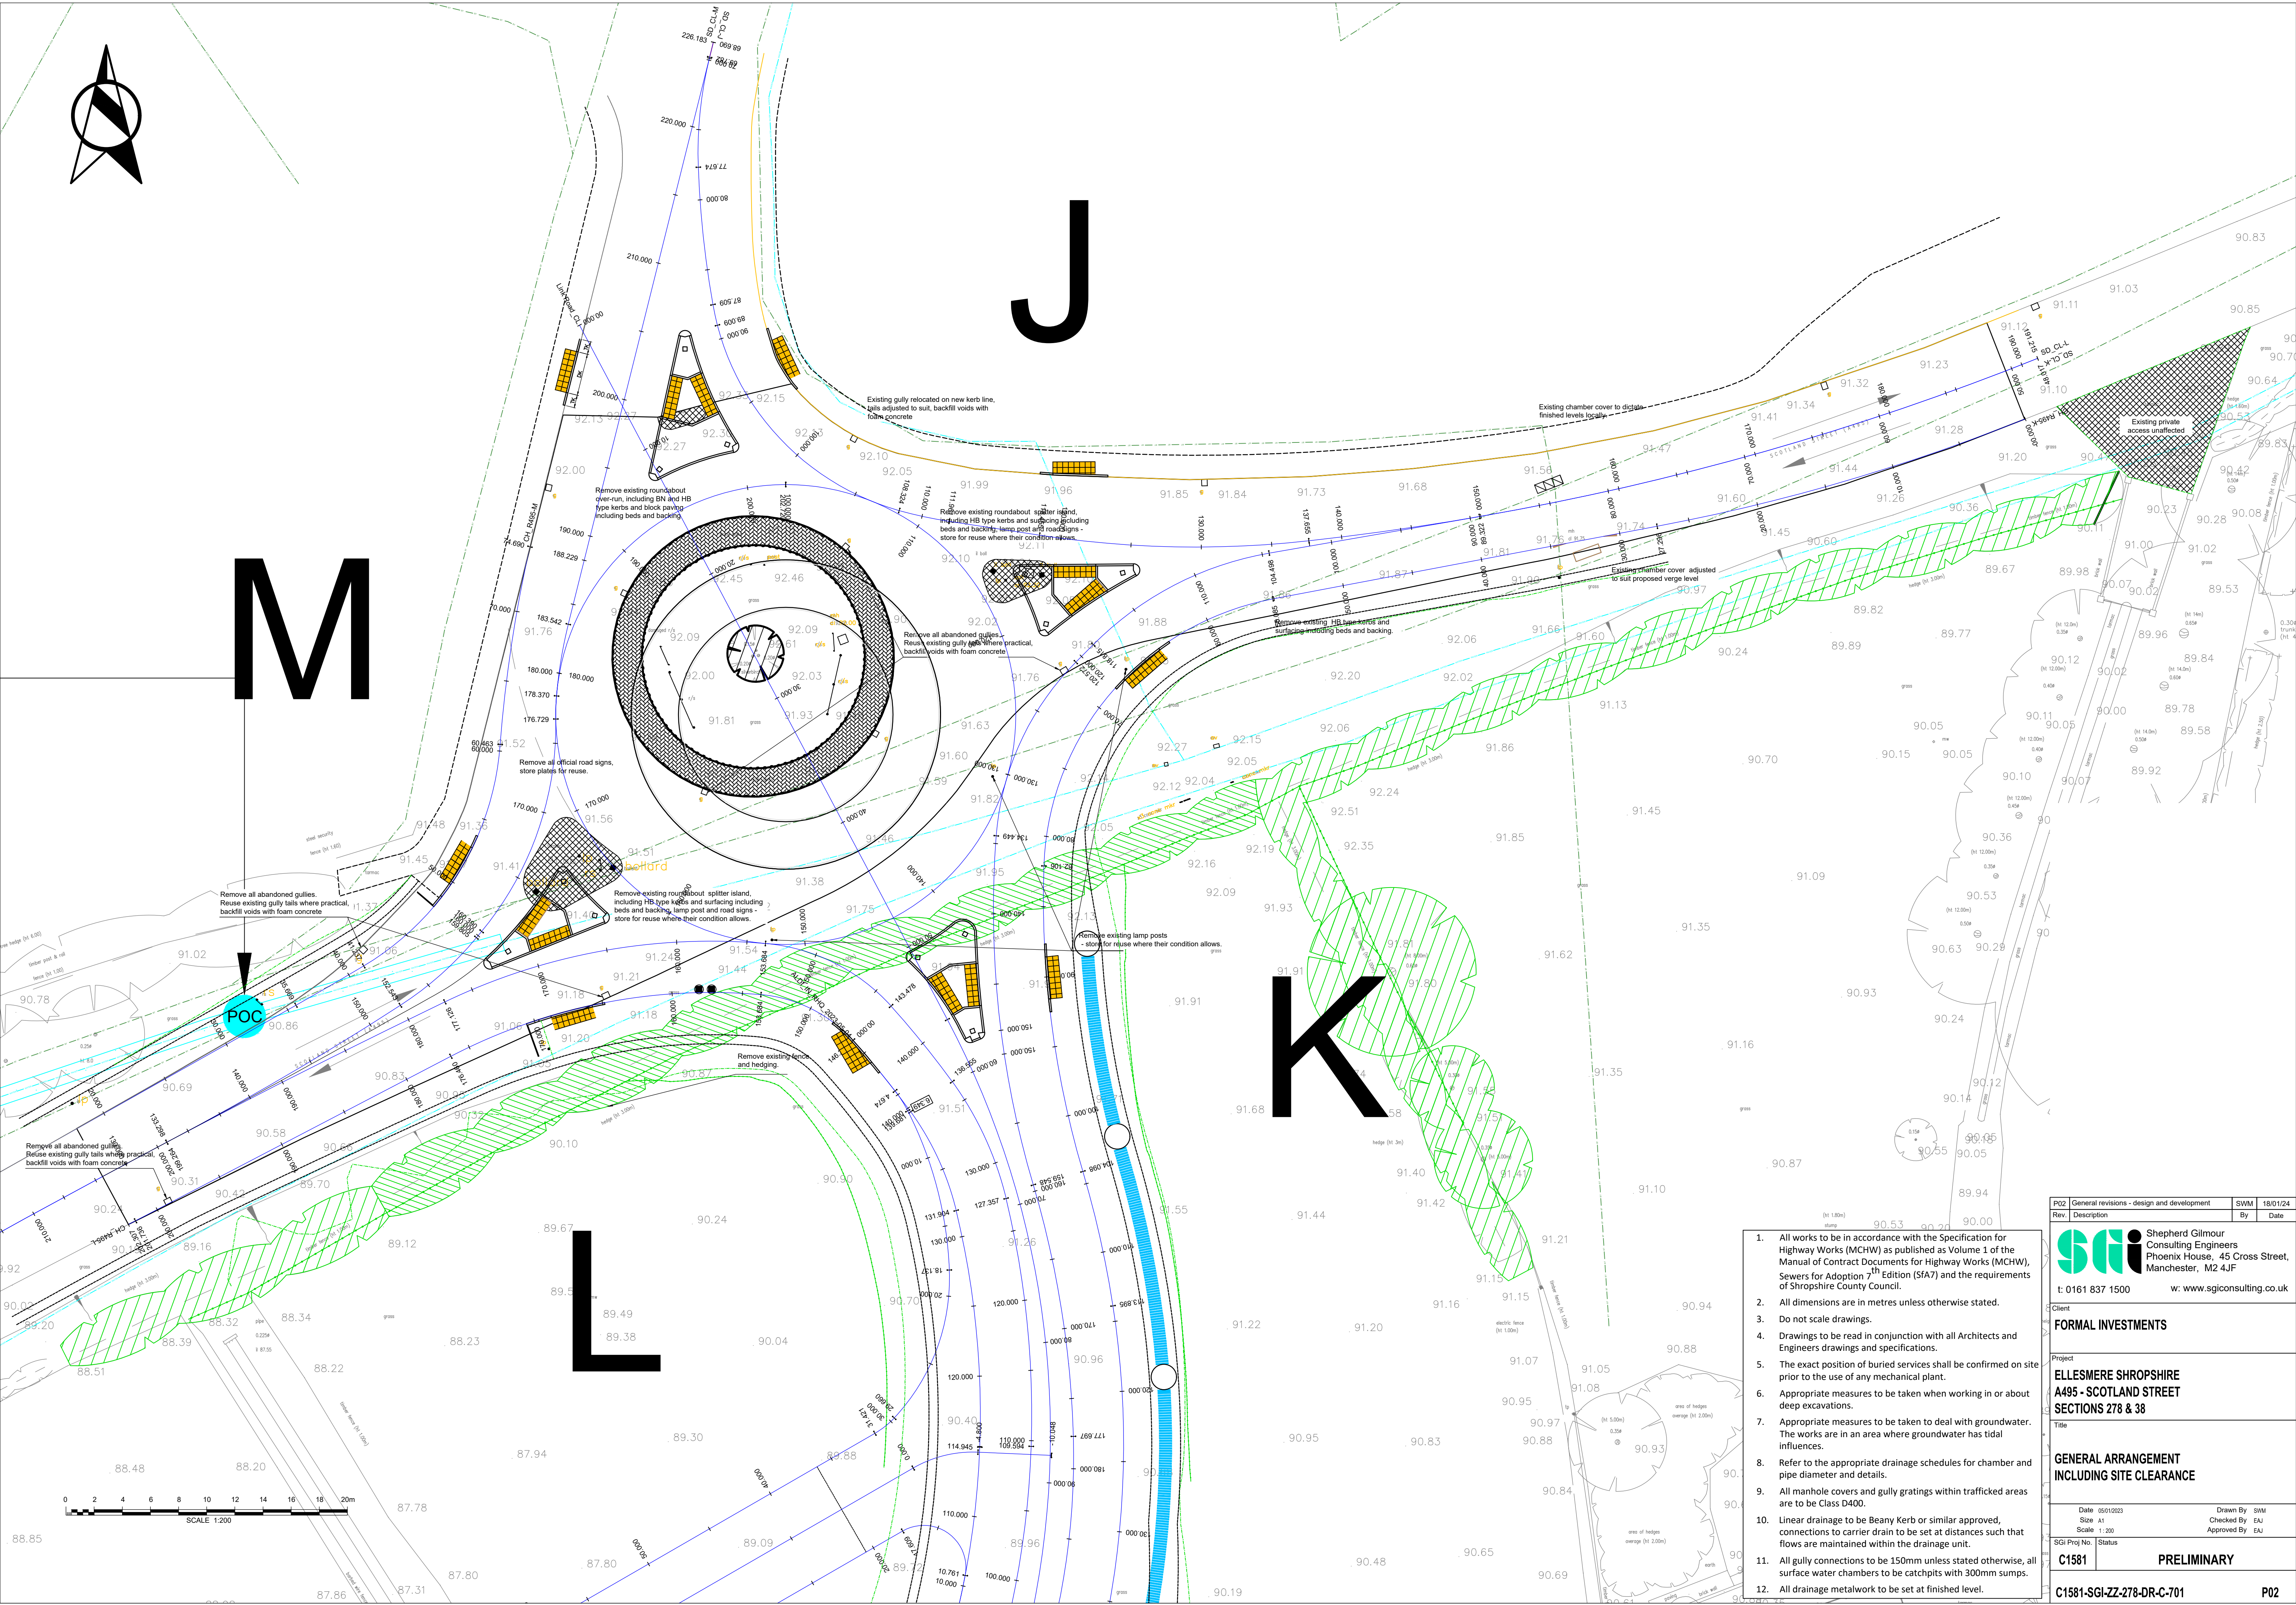

1. All works to be in accordance with the Specification for Highway Works (MCHW) as published as Volume 1 of the Manual of Contract Documents for Highway Works (MCHW), Sewers for Adoption 7th Edition (SFA7) and the requirements of Shropshire County Council.
2. All dimensions are in metres unless otherwise stated.
3. Do not scale drawings.
4. Drawings to be read in conjunction with all Architects and Engineers drawings and specifications.
5. The exact position of buried services shall be confirmed on site prior to the use of any mechanical plant.
6. Appropriate measures to be taken when working in or about deep excavations.
7. Appropriate measures to be taken to deal with groundwater. The works are in an area where groundwater has tidal influences.
8. Refer to the appropriate drainage schedules for chamber and pipe diameter and details.
9. All manhole covers and gully gratings within trafficked areas are to be Class D400.
10. Linear drainage to be Beany Kerb or similar approved, connections to carrier drain to be set at distances such that flows are maintained within the drainage unit.
11. All gully connections to be 150mm unless stated otherwise, all surface water chambers to be catchpits with 300mm sumps.
12. All drainage metalwork to be set at finished level.

P02 General revisions - design and development		SWM	18/01/24
Rev	Description	By	Date
 Shepherd Gilmore Consulting Engineers Phoenix House, 45 Cross Street, Manchester, M2 4JF t: 0161 837 1500 w: www.sgiconsulting.co.uk			
Client			
FORMAL INVESTMENTS			
Project			
ELLESMERE SHROPSHIRE A495 - SCOTLAND STREET SECTIONS 278 & 38			
Title			
GENERAL ARRANGEMENT INCLUDING SITE CLEARANCE			
Date: 05/01/2023		Drawn By: SWM	
Size: A1		Checked By: EAU	
Scale: 1:200		Approved By: EAU	
SGI Proj No: Status			
C1581		PRELIMINARY	
C1581-SGI-ZZ-278-DR-C-701			P02